


FIRST FLOOR PLAN

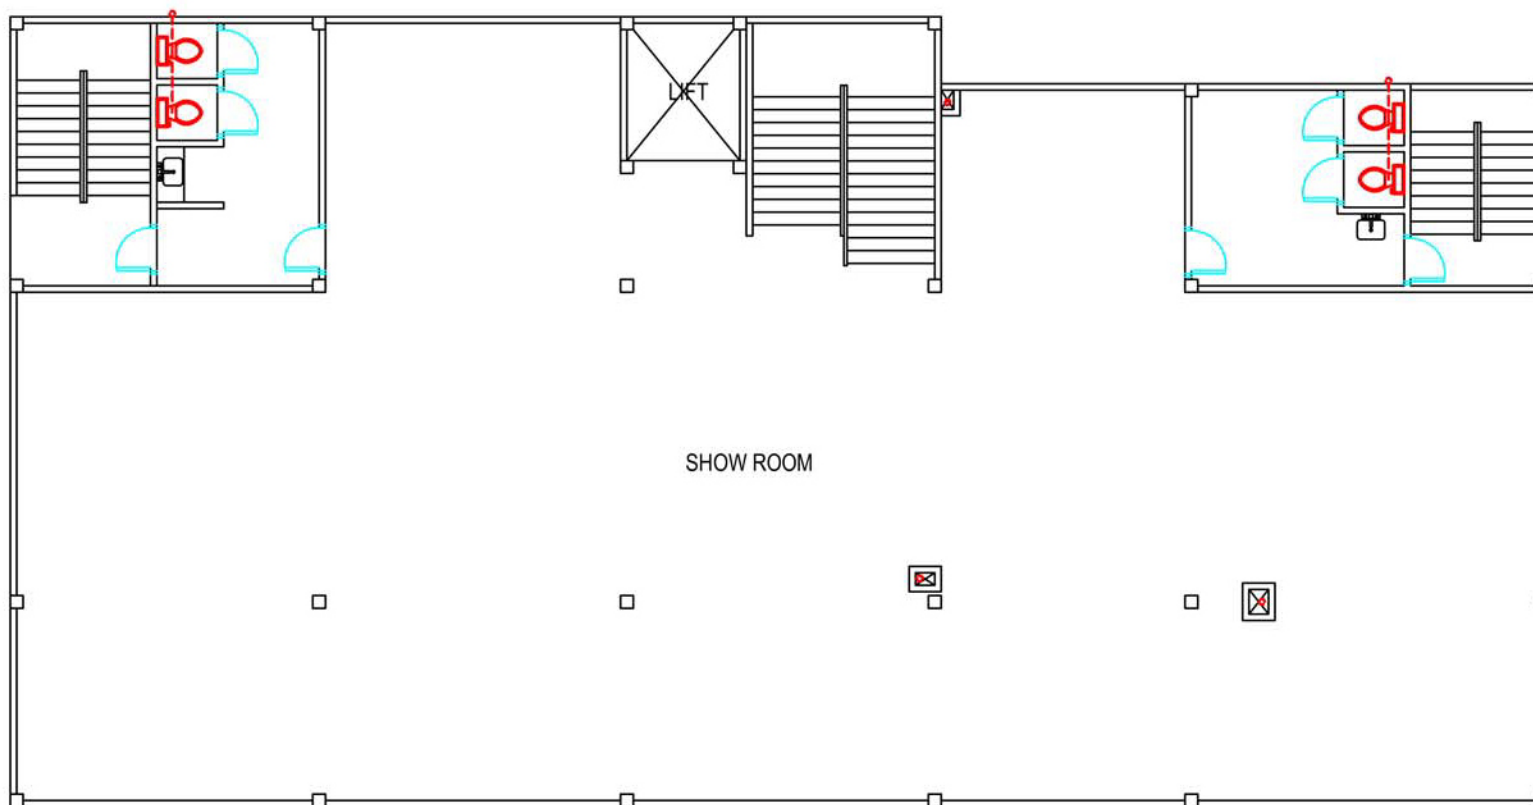

SECOND FLOOR PLAN

OWNER / APPLICANT

DAW HLA
 NO.1, A ROAD, AA WARD
 AAA TOWNSHIP

PROJECT


PROPOSED
 SEPTIC TANK WITH ANAEROBIC
 UPFLOW FILTER SYSTEM
 FOR () PERSONS & SANITARY
 INSTALLATIONS

BLOCK NO


LOT NO

SCALE

1" = 8'.00"

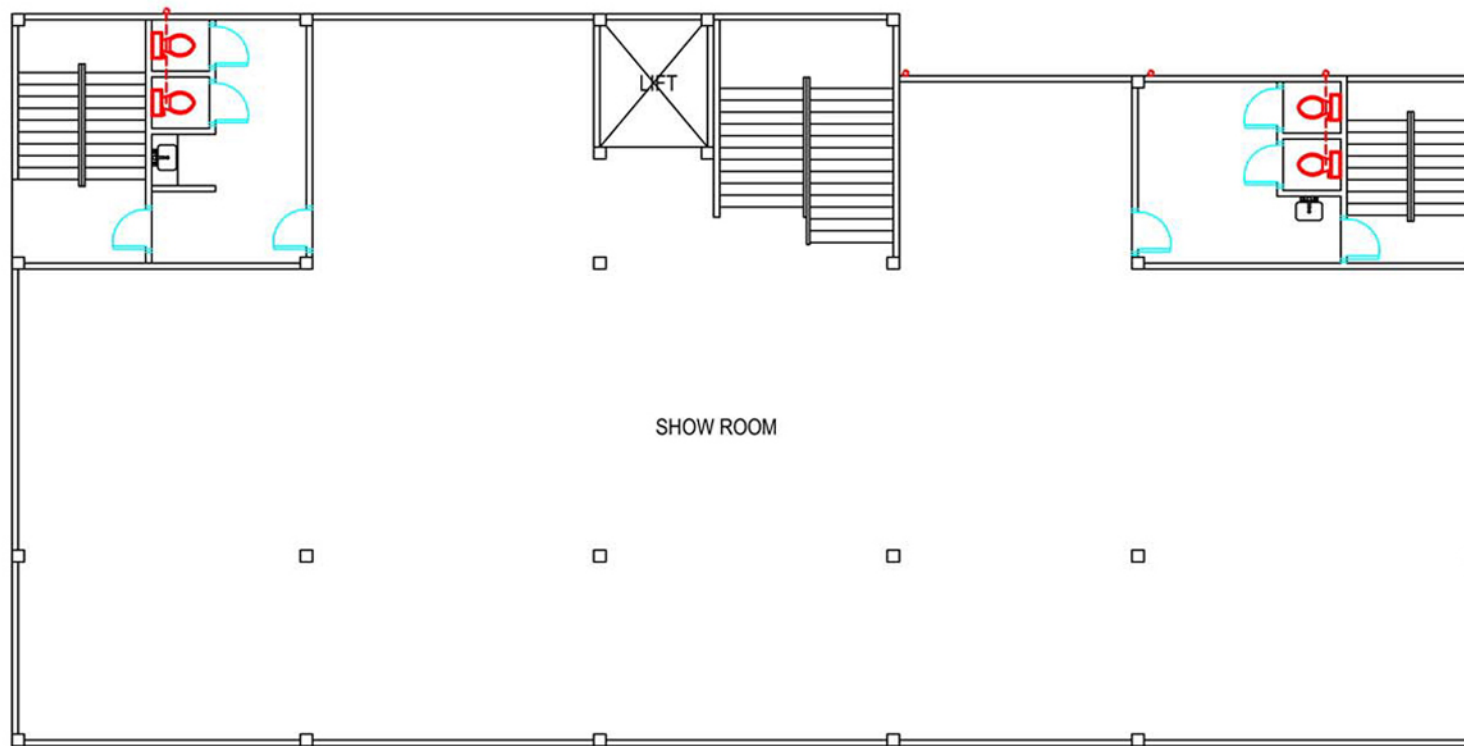

THIRD & FOURTH FLOOR PLAN

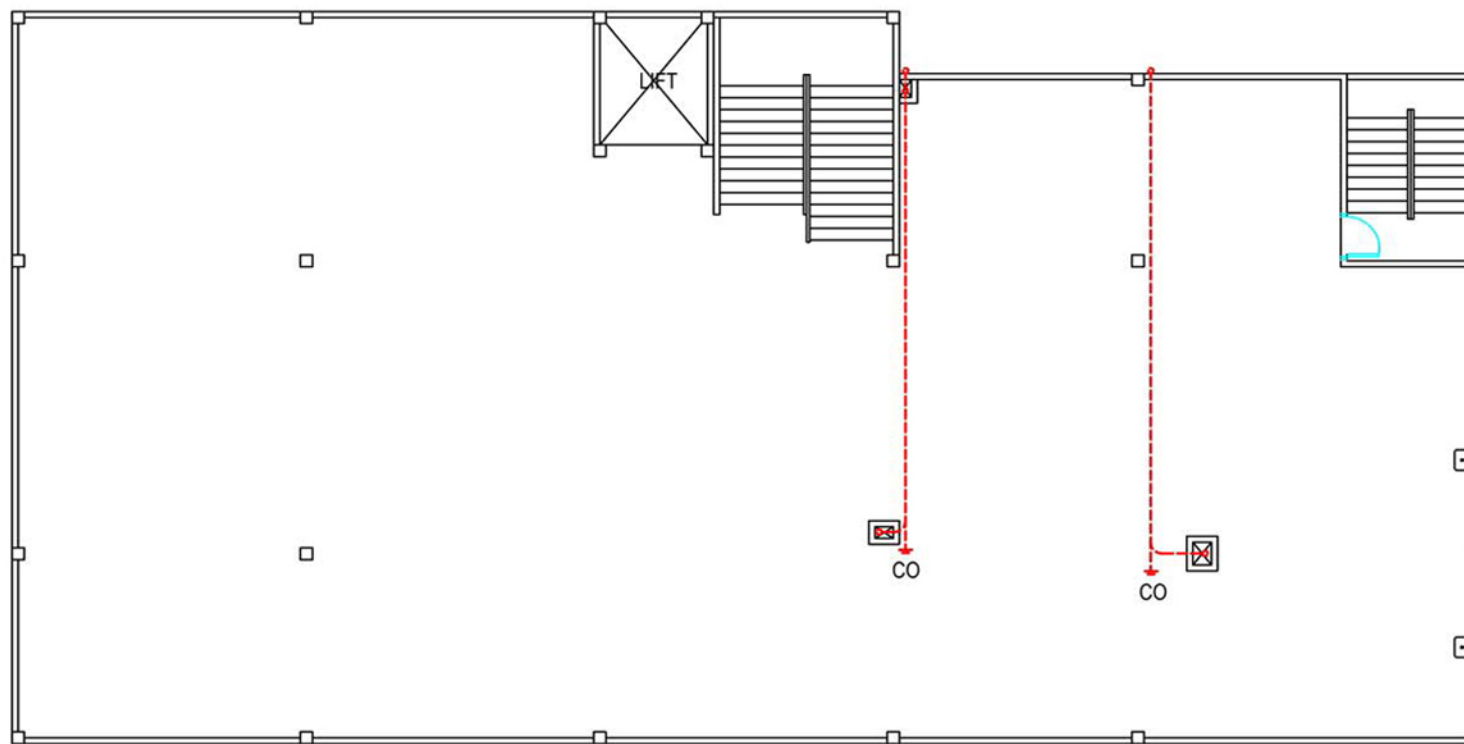

FOURTH FLOOR CEILING PLAN

OWNER / APPLICANT

DAW HLA
 NO.1, A ROAD, AA WARD
 AAA TOWNSHIP


PROJECT	PROPOSED SEPTIC TANK WITH ANAEROBIC UPFLOW FILTER SYSTEM FOR () PERSONS & SANITARY INSTALLATIONS	
	BLOCK NO	

LOT NO

SCALE	1" = 8'.00"
--------------	--------------------


PROPOSED NOTES

- (1) NO.110 PERSONS SEPTIC TANK
- (22) NOS EWC
- (1) LINE 4" Ø SOIL PIPE (each riser)
- (1) LINE 2" Ø VENT PIPE (each riser)
- (1) LINE 3" Ø WASTE PIPE (each riser)

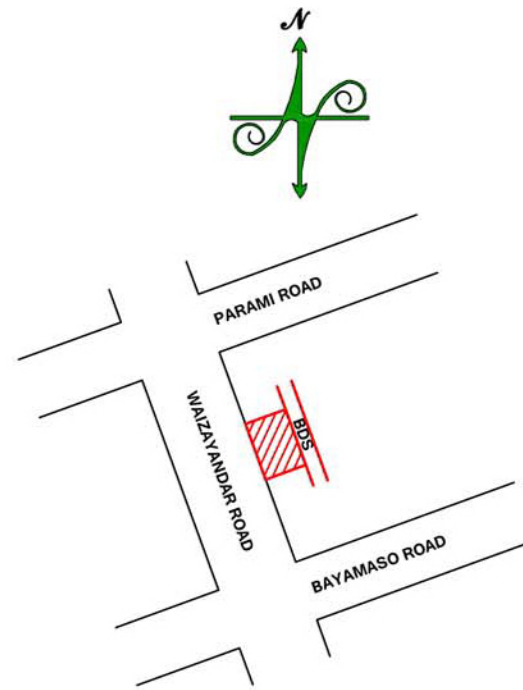

SITE LOCATION PLAN

(Not to scale)

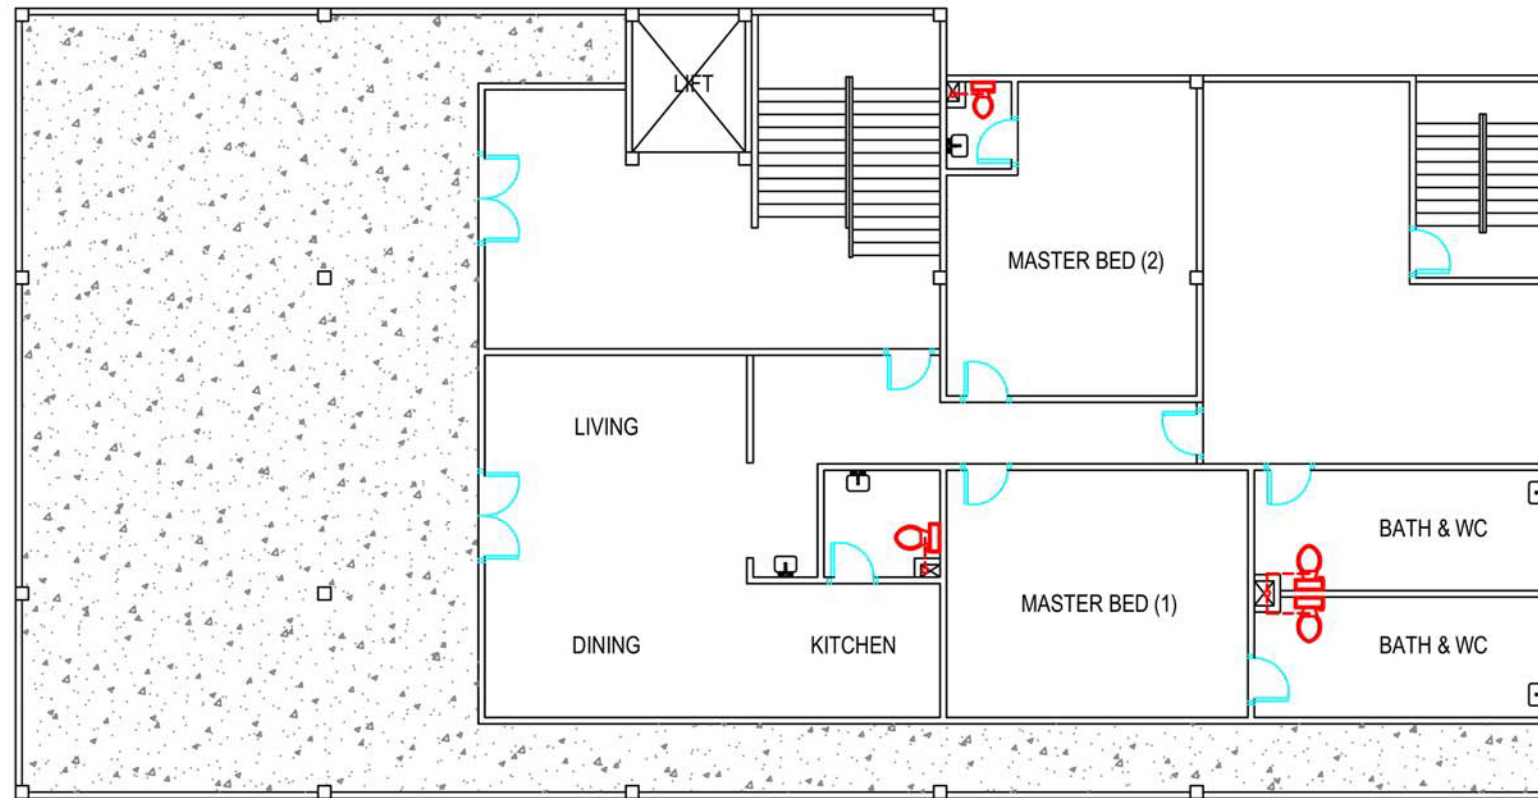

FIFTH FLOOR PLAN

OWNER / APPLICANT


DAW HLA
 NO.1, A ROAD, AA WARD
 AAA TOWNSHIP

PROJECT **PROPOSED**
SEPTIC TANK WITH ANAEROBIC
UPFLOW FILTER SYSTEM
FOR () PERSONS & SANITARY
INSTALLATIONS


BLOCK NO

LOT NO

SCALE 1" = 8'.00"

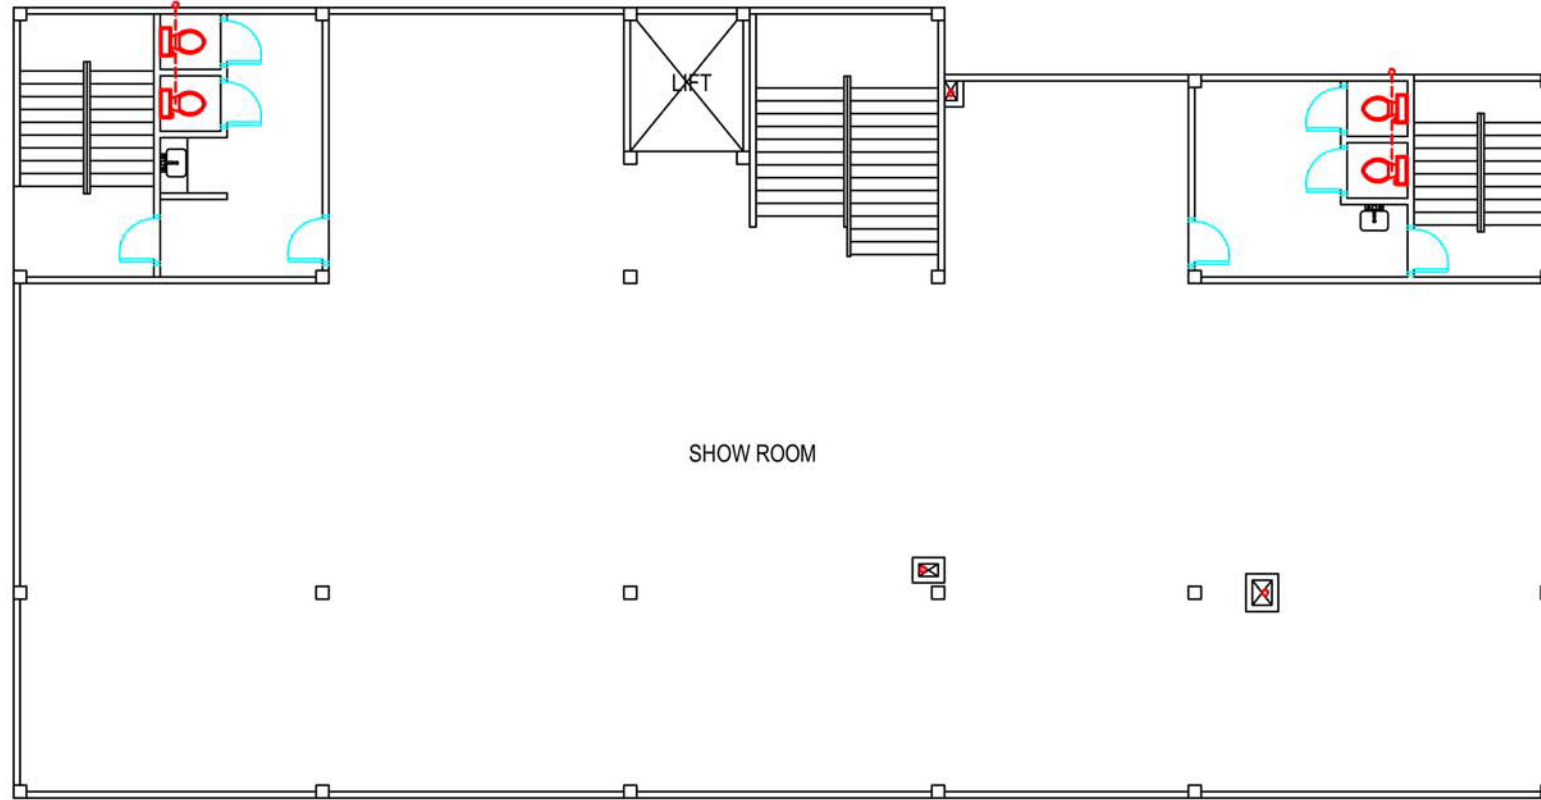

THIRD & FOURTH FLOOR PLAN

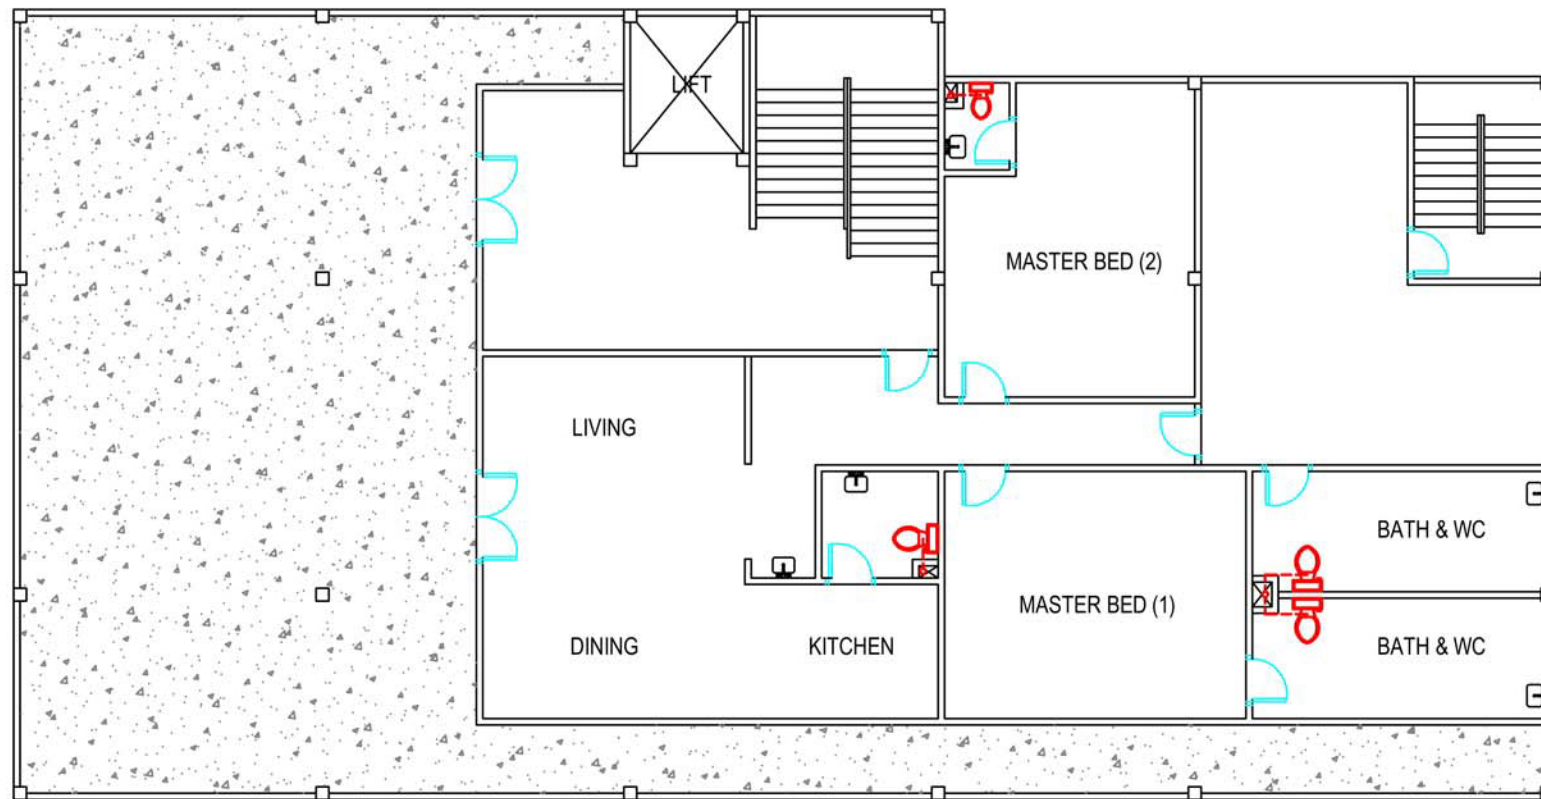

FIFTH FLOOR PLAN

OWNER / APPLICANT


DAW HLA
 NO.1, A ROAD, AA WARD
 AAA TOWNSHIP

PROJECT **PROPOSED**
SEPTIC TANK WITH ANAEROBIC
UPFLOW FILTER SYSTEM
FOR () PERSONS & SANITARY
INSTALLATIONS

BLOCK NO

LOT NO

SCALE 1" = 8'.00"

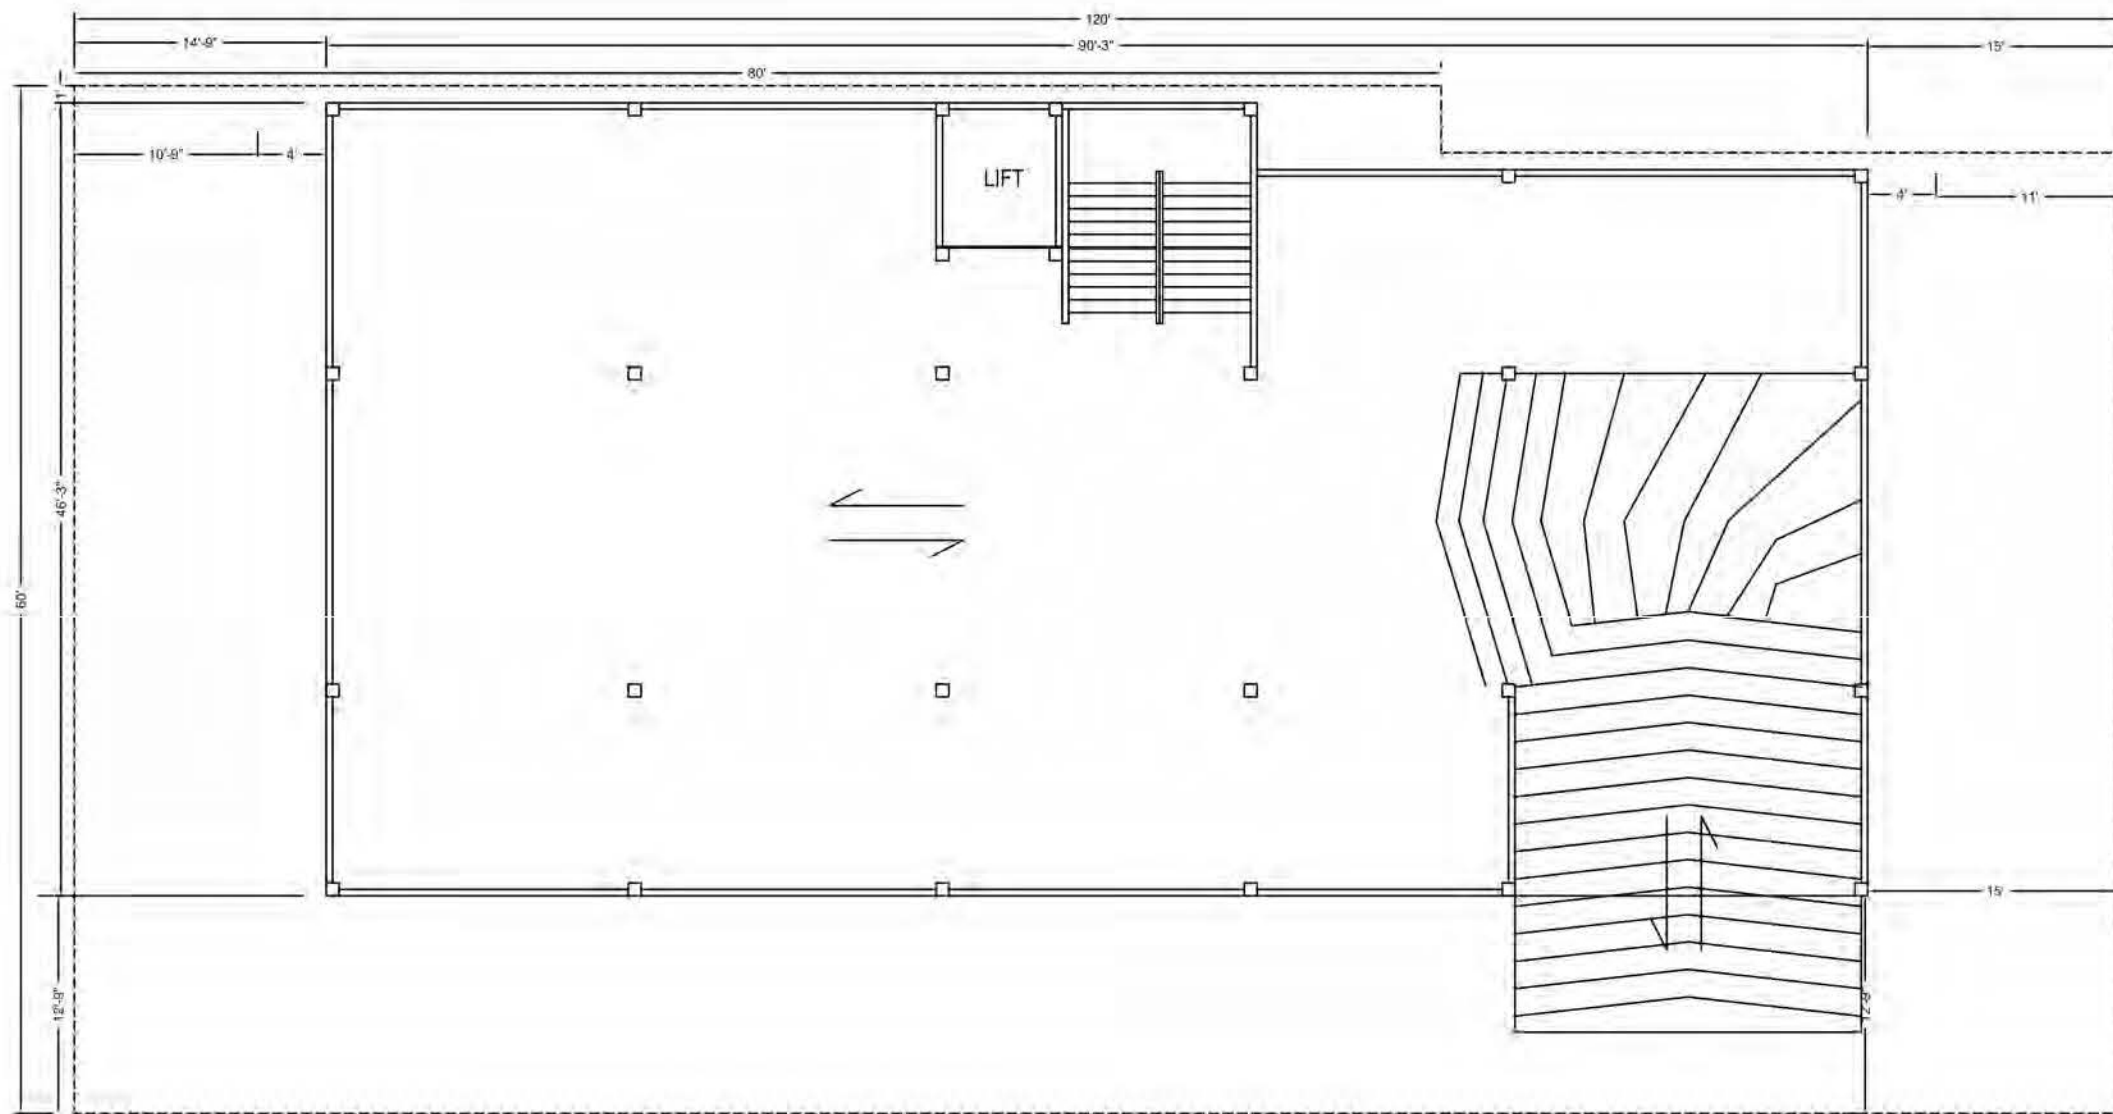

BASEMENT FLOOR PLAN

OWNER / APPLICANT

DAW HLA
 NO.1, A ROAD, AA WARD
 AAA TOWNSHIP

PROJECT


**PROPOSED
 SEPTIC TANK WITH ANAEROBIC
 UPFLOW FILTER SYSTEM
 FOR () PERSONS & SANITARY
 INSTALLATIONS**

BLOCK NO

LOT NO

SCALE

1" = 8'.00"

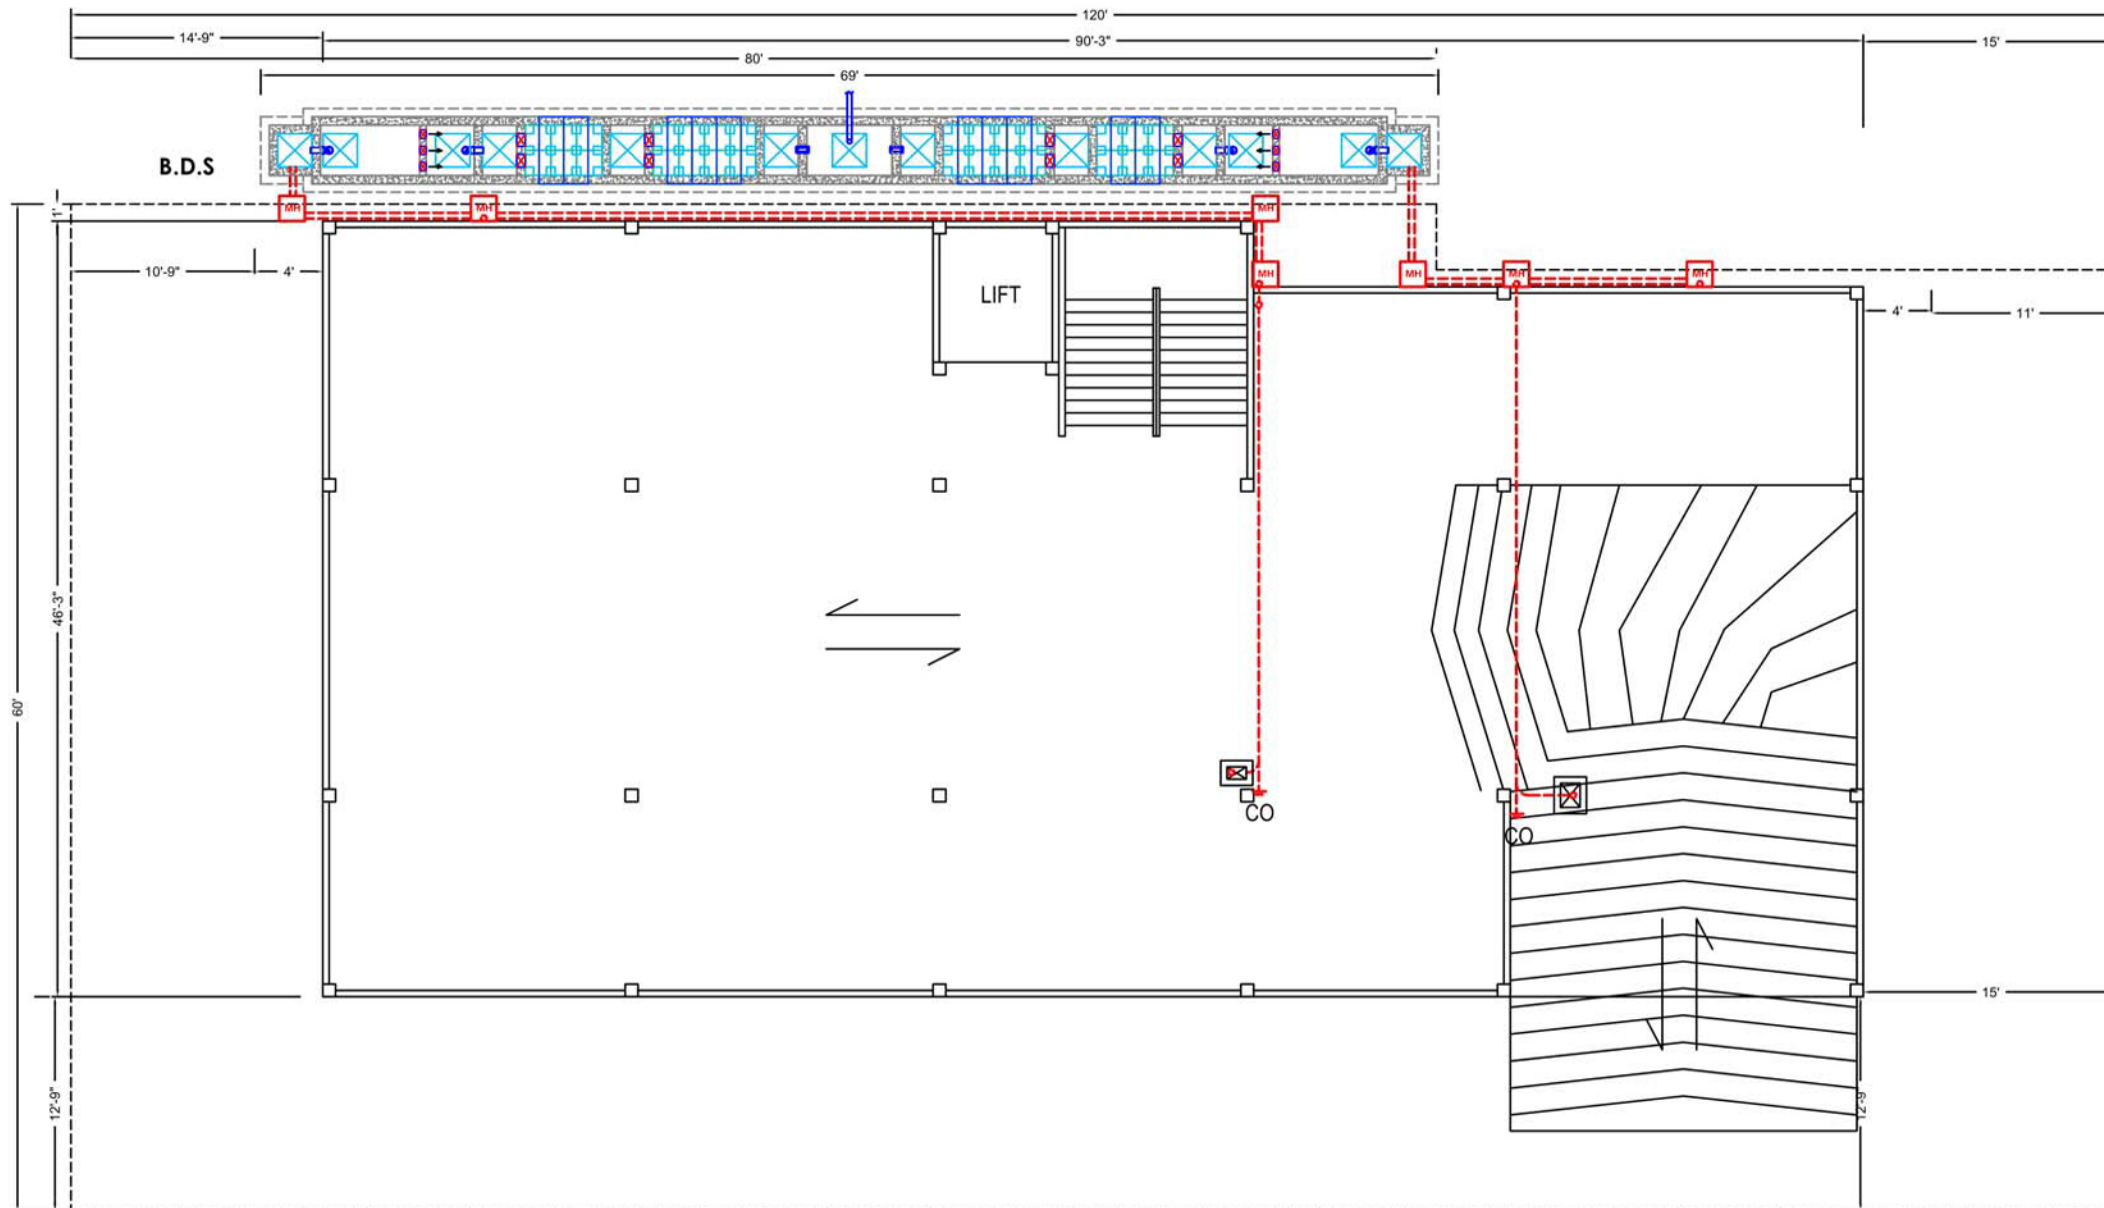

BASEMENT CEILING PLAN

OWNER / APPLICANT

DAW HLA
 NO.1, A ROAD, AA WARD
 AAA TOWNSHIP

PROJECT

**PROPOSED
 SEPTIC TANK WITH ANAEROBIC
 UPFLOW FILTER SYSTEM
 FOR () PERSONS & SANITARY
 INSTALLATIONS**

BLOCK NO


LOT NO

SCALE

1" = 8'.00"


PROPOSED NOTES

- (1) NO.110 PERSONS SEPTIC TANK
- (22) NOS EWC
- (1) LINE 4" Ø SOIL PIPE (each riser)
- (1) LINE 2" Ø VENT PIPE (each riser)
- (1) LINE 3" Ø WASTE PIPE (each riser)

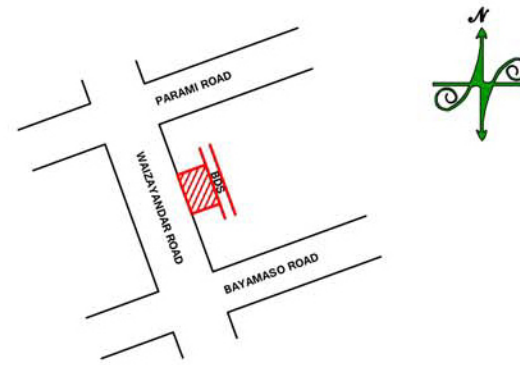

SITE LOCATION PLAN

(Not to scale)

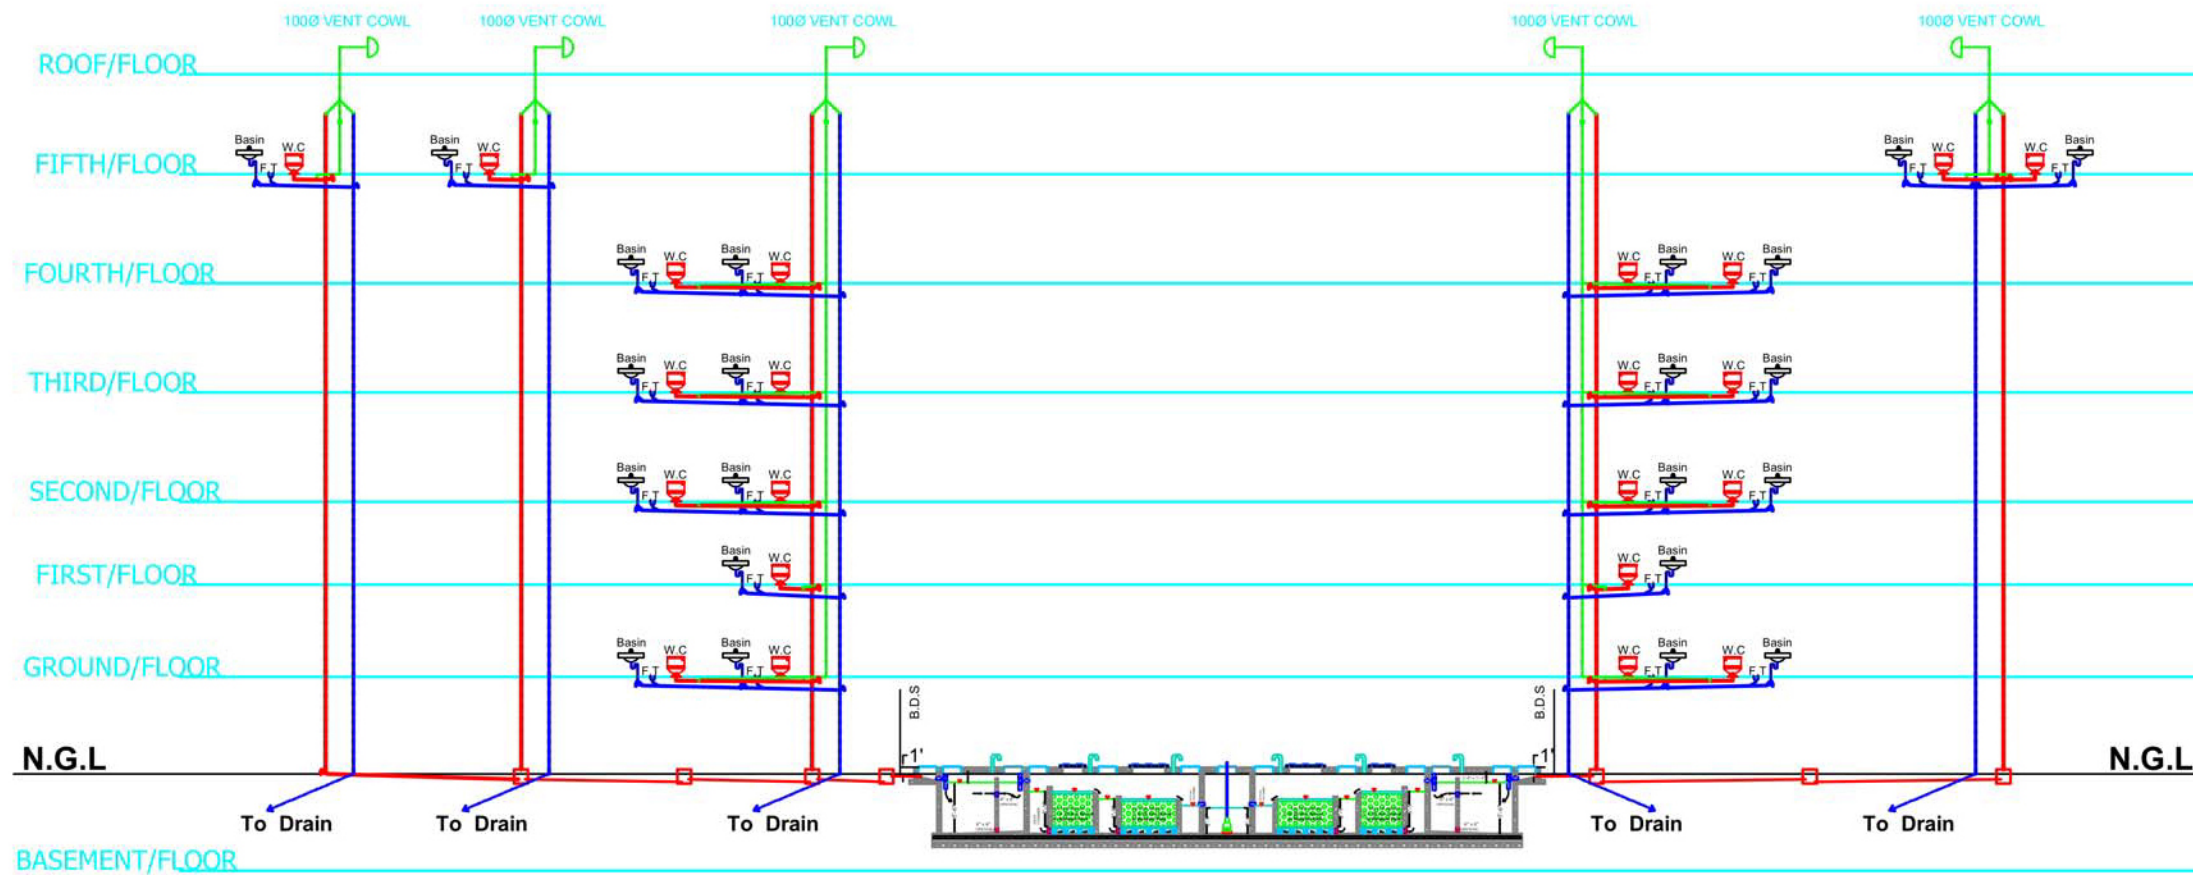

SCHEMATIC DIAGRAM FOR SANITATION SYSTEM

OWNER / APPLICANT

DAW HLA
NO.1, A ROAD, AA WARD
AAA TOWNSHIP




PROJECT **PROPOSED SEPTIC TANK WITH ANAEROBIC UPFLOW FILTER SYSTEM FOR () PERSONS & SANITARY INSTALLATIONS**

BLOCK NO

LOT NO

SCALE 1" = 8'.00"

SEPTIC TANK FOR () PERSONS

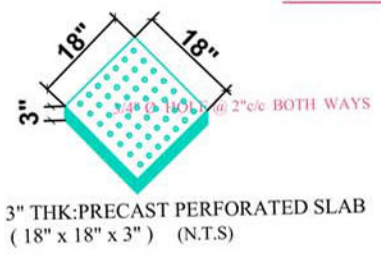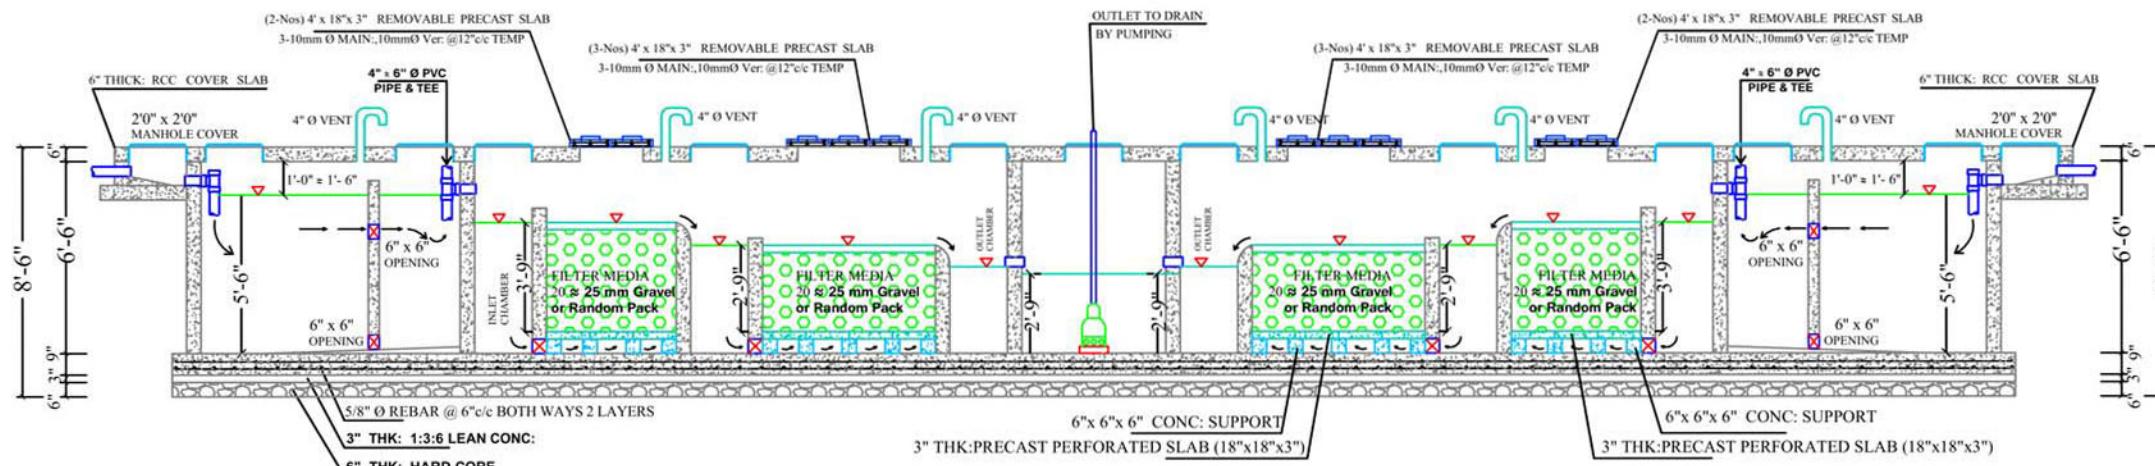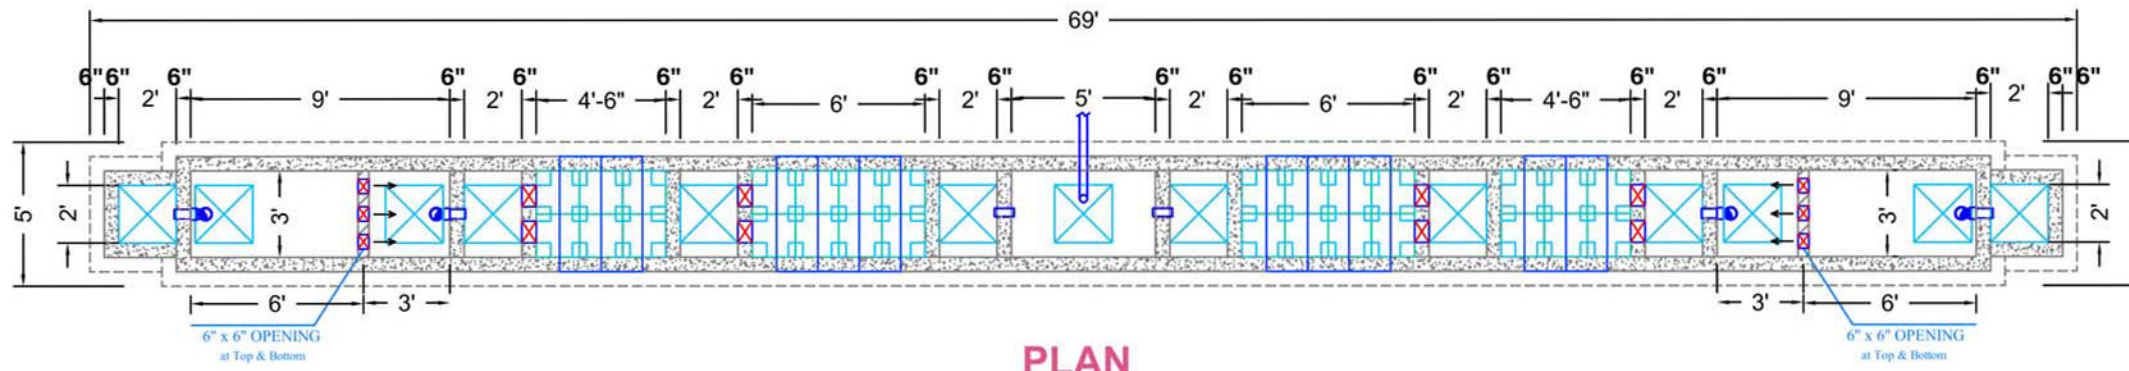

OWNER / APPLICANT

DAW HLA
NO.1, A ROAD, AA WARD
AAA TOWNSHIP

PROJECT

**PROPOSED
SEPTIC TANK WITH ANAEROBIC
UPFLOW FILTER SYSTEM
FOR () PERSONS & SANITARY
INSTALLATIONS**

BLOCK NO

LOT NO

SCALE

1" = 8'.00"